



MARK	DESCRIPTION	REMARKS
①	BUNN- BREWwise SINGLE SOFT HEAT DBC BREWER	ELECTRICAL & PLUMBING REQUIRED
②	GRINDER SERIES GR2.2 & GR2.3 DUAL HOPPER	ELECTRICAL REQUIRED
③	BUNN- SH SERVERS, STANDS & DOCKING SYSTEM (3 EA)	ELECTRICAL REQUIRED
④	BUNN- ICED TEA BREWER & DISPENSERS	ELECTRICAL & PLUMBING REQUIRED
⑤	LANCER-MEDALLION IBD-4500-8 VALVE-SODA/ICE DISPENSER	ELECTRICAL & PLUMBING REQUIRED

BEVERAGE EQUIPMENT LIST      NTS      5

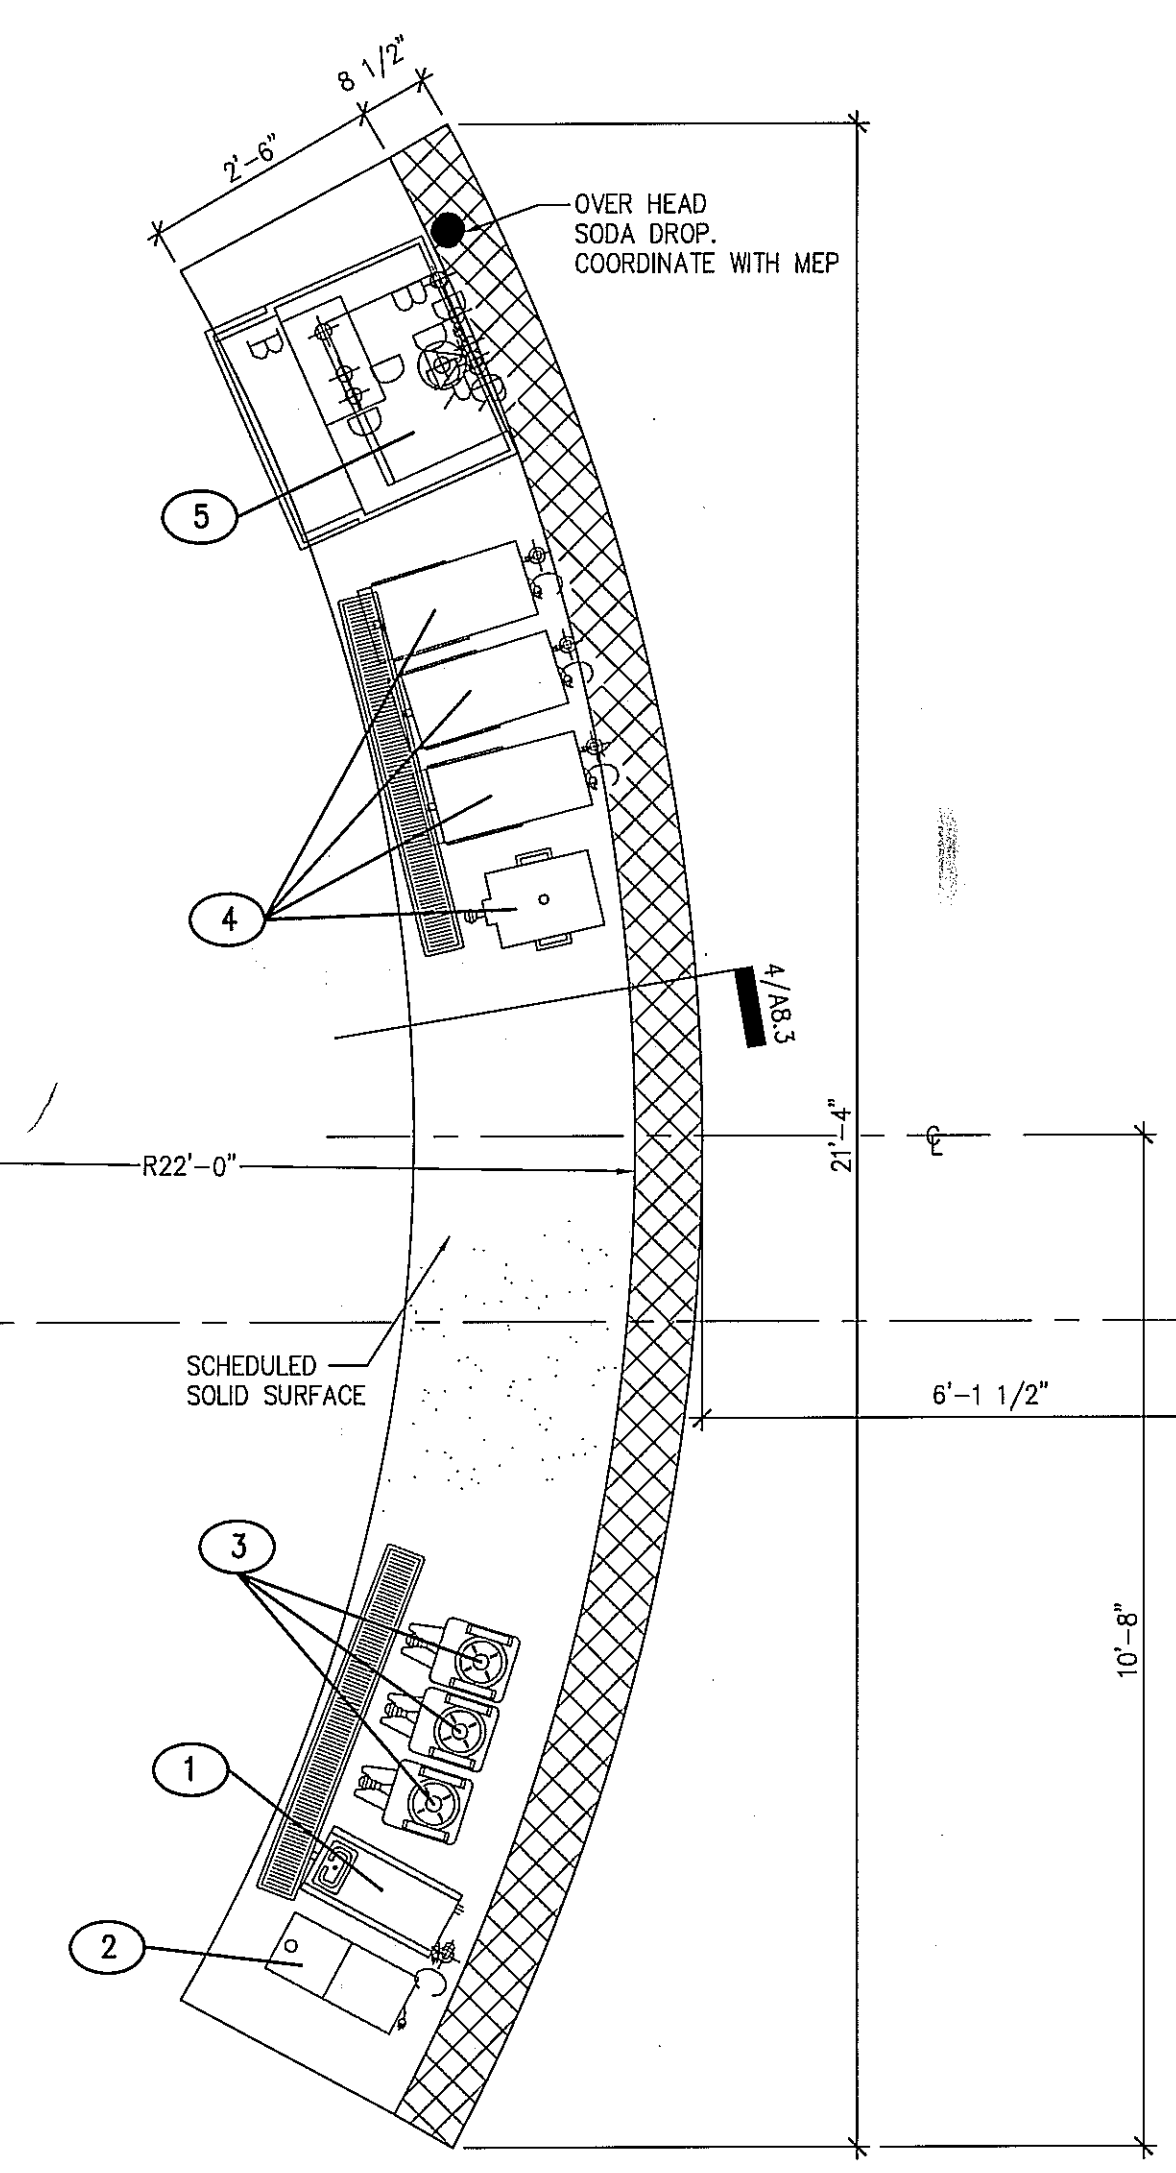


ENLARGED FLOOR PLAN- BEVERAGE COUNTER

1/2" = 1'-0"      2

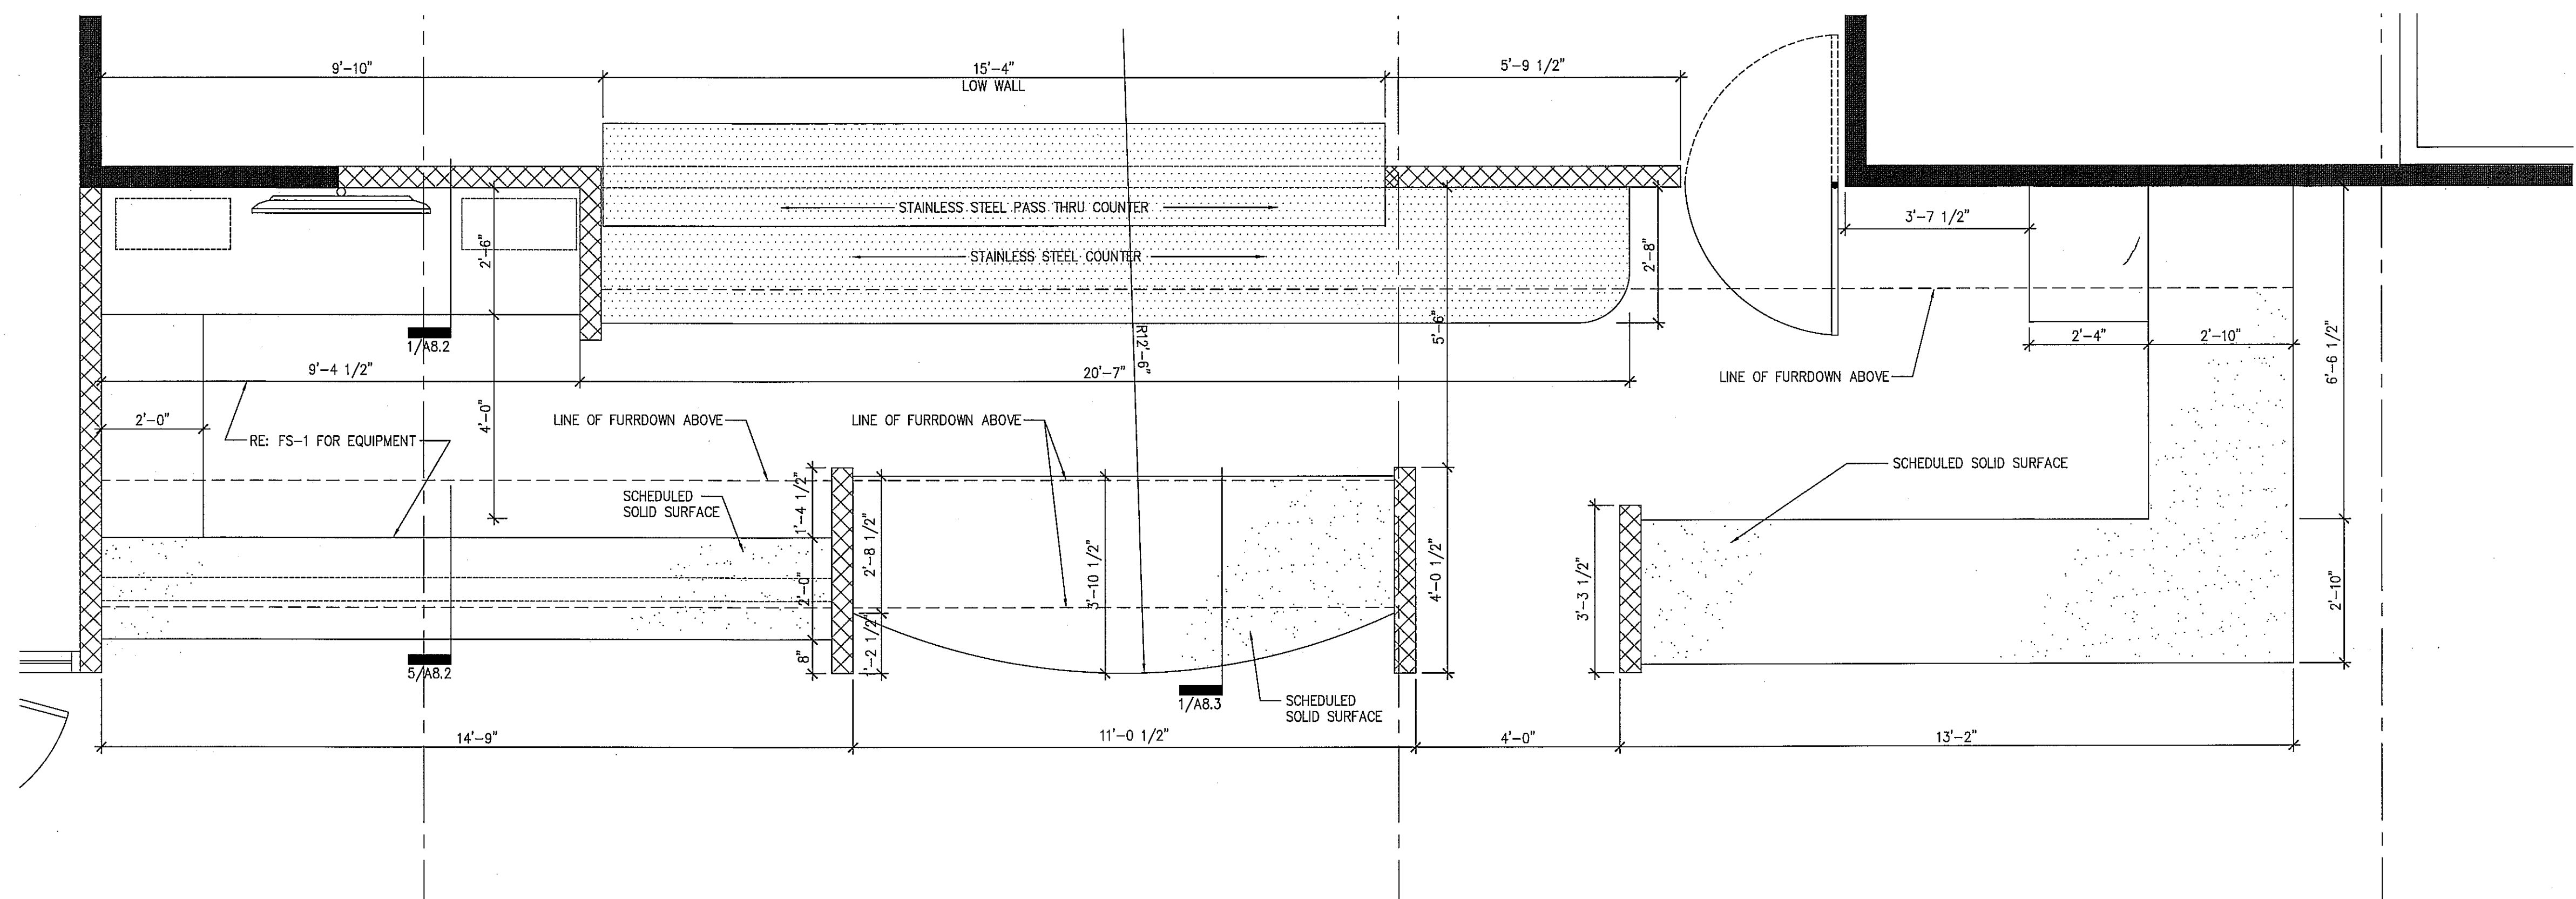

ENLARGED FLOOR PLAN

1/2" = 1'-0"      1

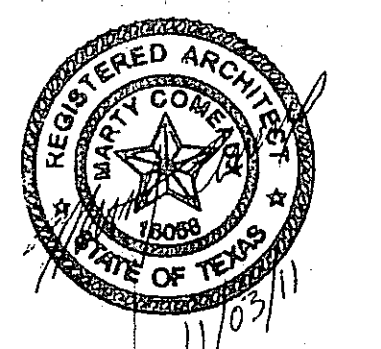

ISSUE  
11-03-11 ISSUED FOR PERMIT/ PRICING

**HARRELL**  
ARCHITECTS, LP

9575 Katy Frwy., #200  
Houston, Texas 77024  
tel: 713.722.7071  
fax: 713.722.7072

CONSULTANTS  
Holste & Associates, Inc.  
MEP Engineers

PROJECT NAME



Cafe Express Restaurant  
PROJECT ADDRESS  
3800 SW. Freeway, Suite 124  
Houston, Texas 77027

PROJECT NUMBER  
11039

SHEET NAME  
**ENLARGED PLANS**  
SHEET NUMBER

**A8.1**