


**ELECTRICAL KEYED NOTES:**

(FOR SHEET E2.3)

- 1 EMERGENCY EGRESS LIGHT FIXTURE IS TO BE CONNECTED TO UN-SWITCHED LEG OF EXISTING HOUSE EXTERIOR LIGHTING CIRCUIT. FIELD VERIFY EXISTING CONDITIONS.




ISSUE  
 10-24-11 LANDLORD REVIEW  
 11-03-11 ISSUED FOR PERMIT AND PRICING

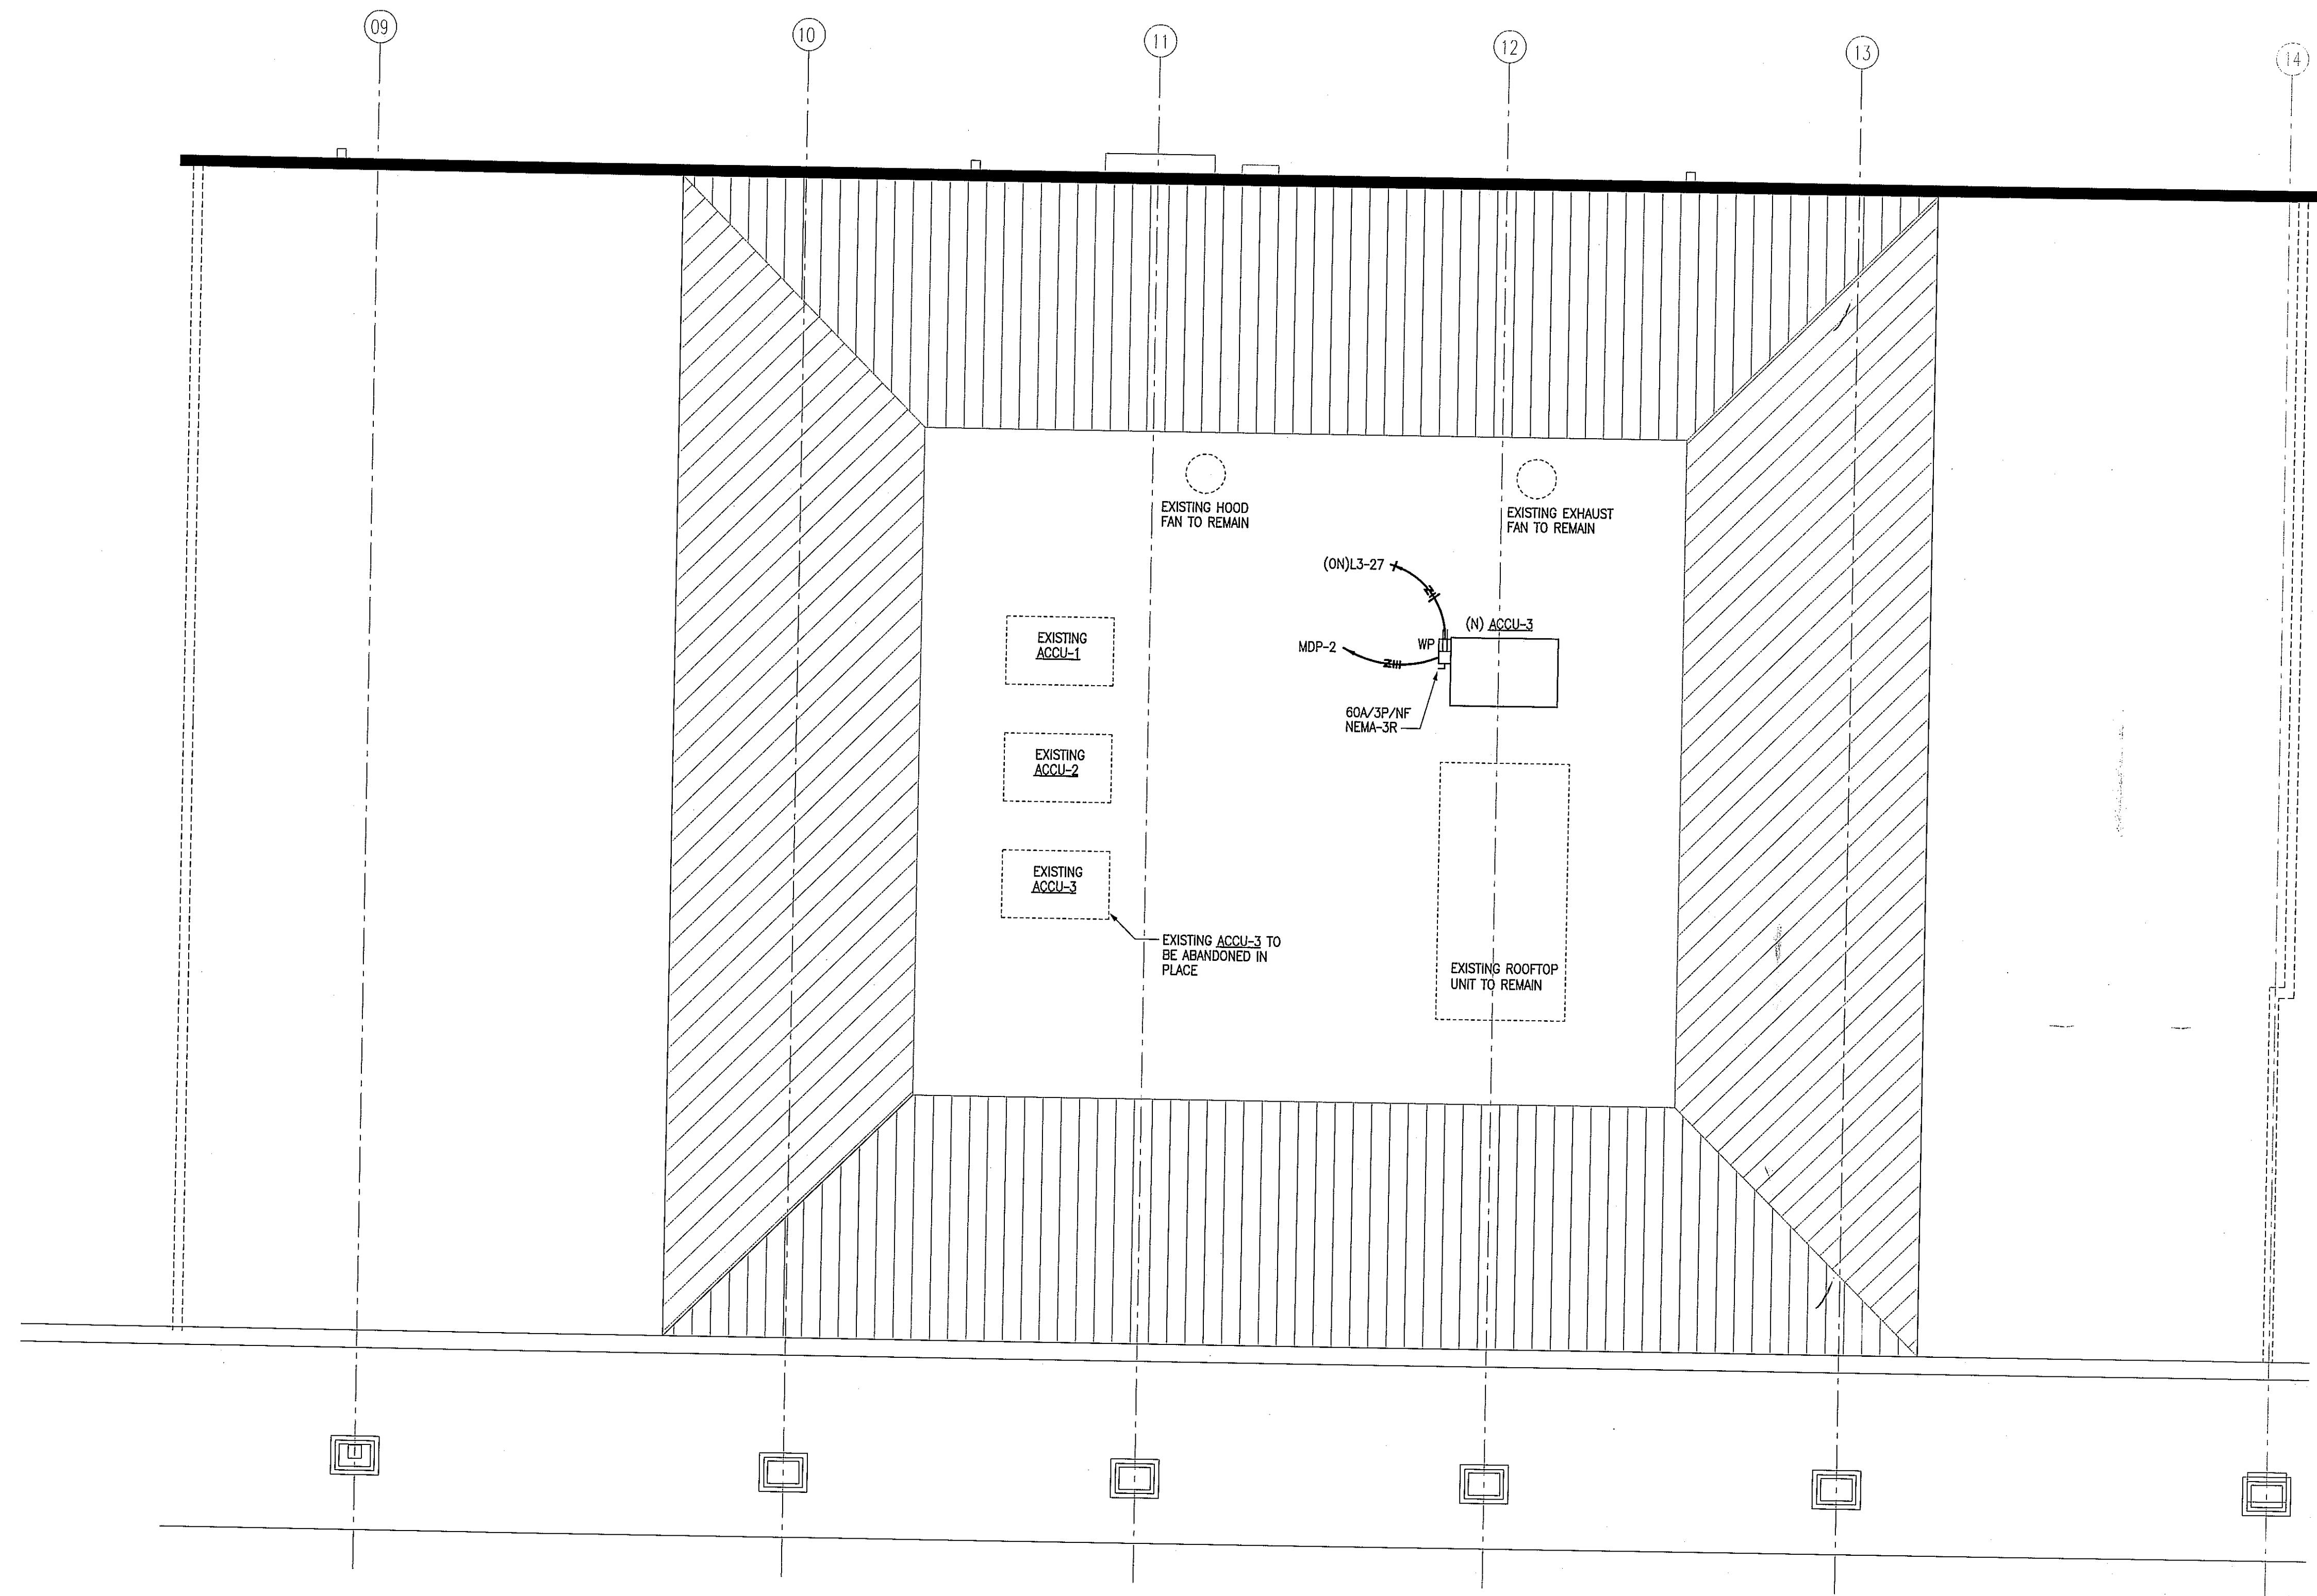

**1 ELECTRICAL ROOF PLAN**  
 SCALE: 3/16" = 1'-0"

**HARRELL**  
 ARCHITECTS, LP

9575 Katy Frwy., #200  
 Houston, Texas 77024  
 tel: 713.722.7074  
 fax: 713.722.7072

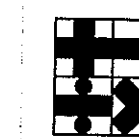CONSULTANTS  

 Holste & Associates, Inc.  
 Consulting Engineers - Texas Reg. F5443  
 6671 Southwest Freeway, Suite 550  
 Houston, Texas 77074 (713) 995-1351  
 www.holsteap.com  
 Contact: Kris Odom (832) 643-0368

PROJECT NAME



Cafe Express Restaurant

PROJECT ADDRESS  
 3800 SW. Freeway, Suite 124  
 Houston, Texas 77027

PROJECT NUMBER

11039

SHEET NAME

**ELECTRICAL  
 ROOF PLAN**

SHEET NUMBER