



ISSUE
10-24-11 LANDLORD REVIEW
11-03-11 ISSUED FOR PERMIT AND PRICING

HARRELL
ARCHITECTS, LP

9575 Katy Frwy., #200
Houston, Texas 77024
tel: 713.722.7071
fax: 713.722.7072

CONSULTANTS
 Holste & Associates, Inc.
Consulting Engineers - Texas Reg. F-5413
6071 Southwest Freeway, Suite 850
Houston, Texas 77057 (713) 995-1351
www.holstenep.com
Contact: Kris Odum (832) 613-0368

PROJECT NAME



Cafe Express Restaurant

PROJECT ADDRESS
3800 SW. Freeway, Suite 124
Houston, Texas 77027

PROJECT NUMBER


11039

SHEET NAME

PLUMBING
RISER DIAGRAMS

SHEET NUMBER

P5.1

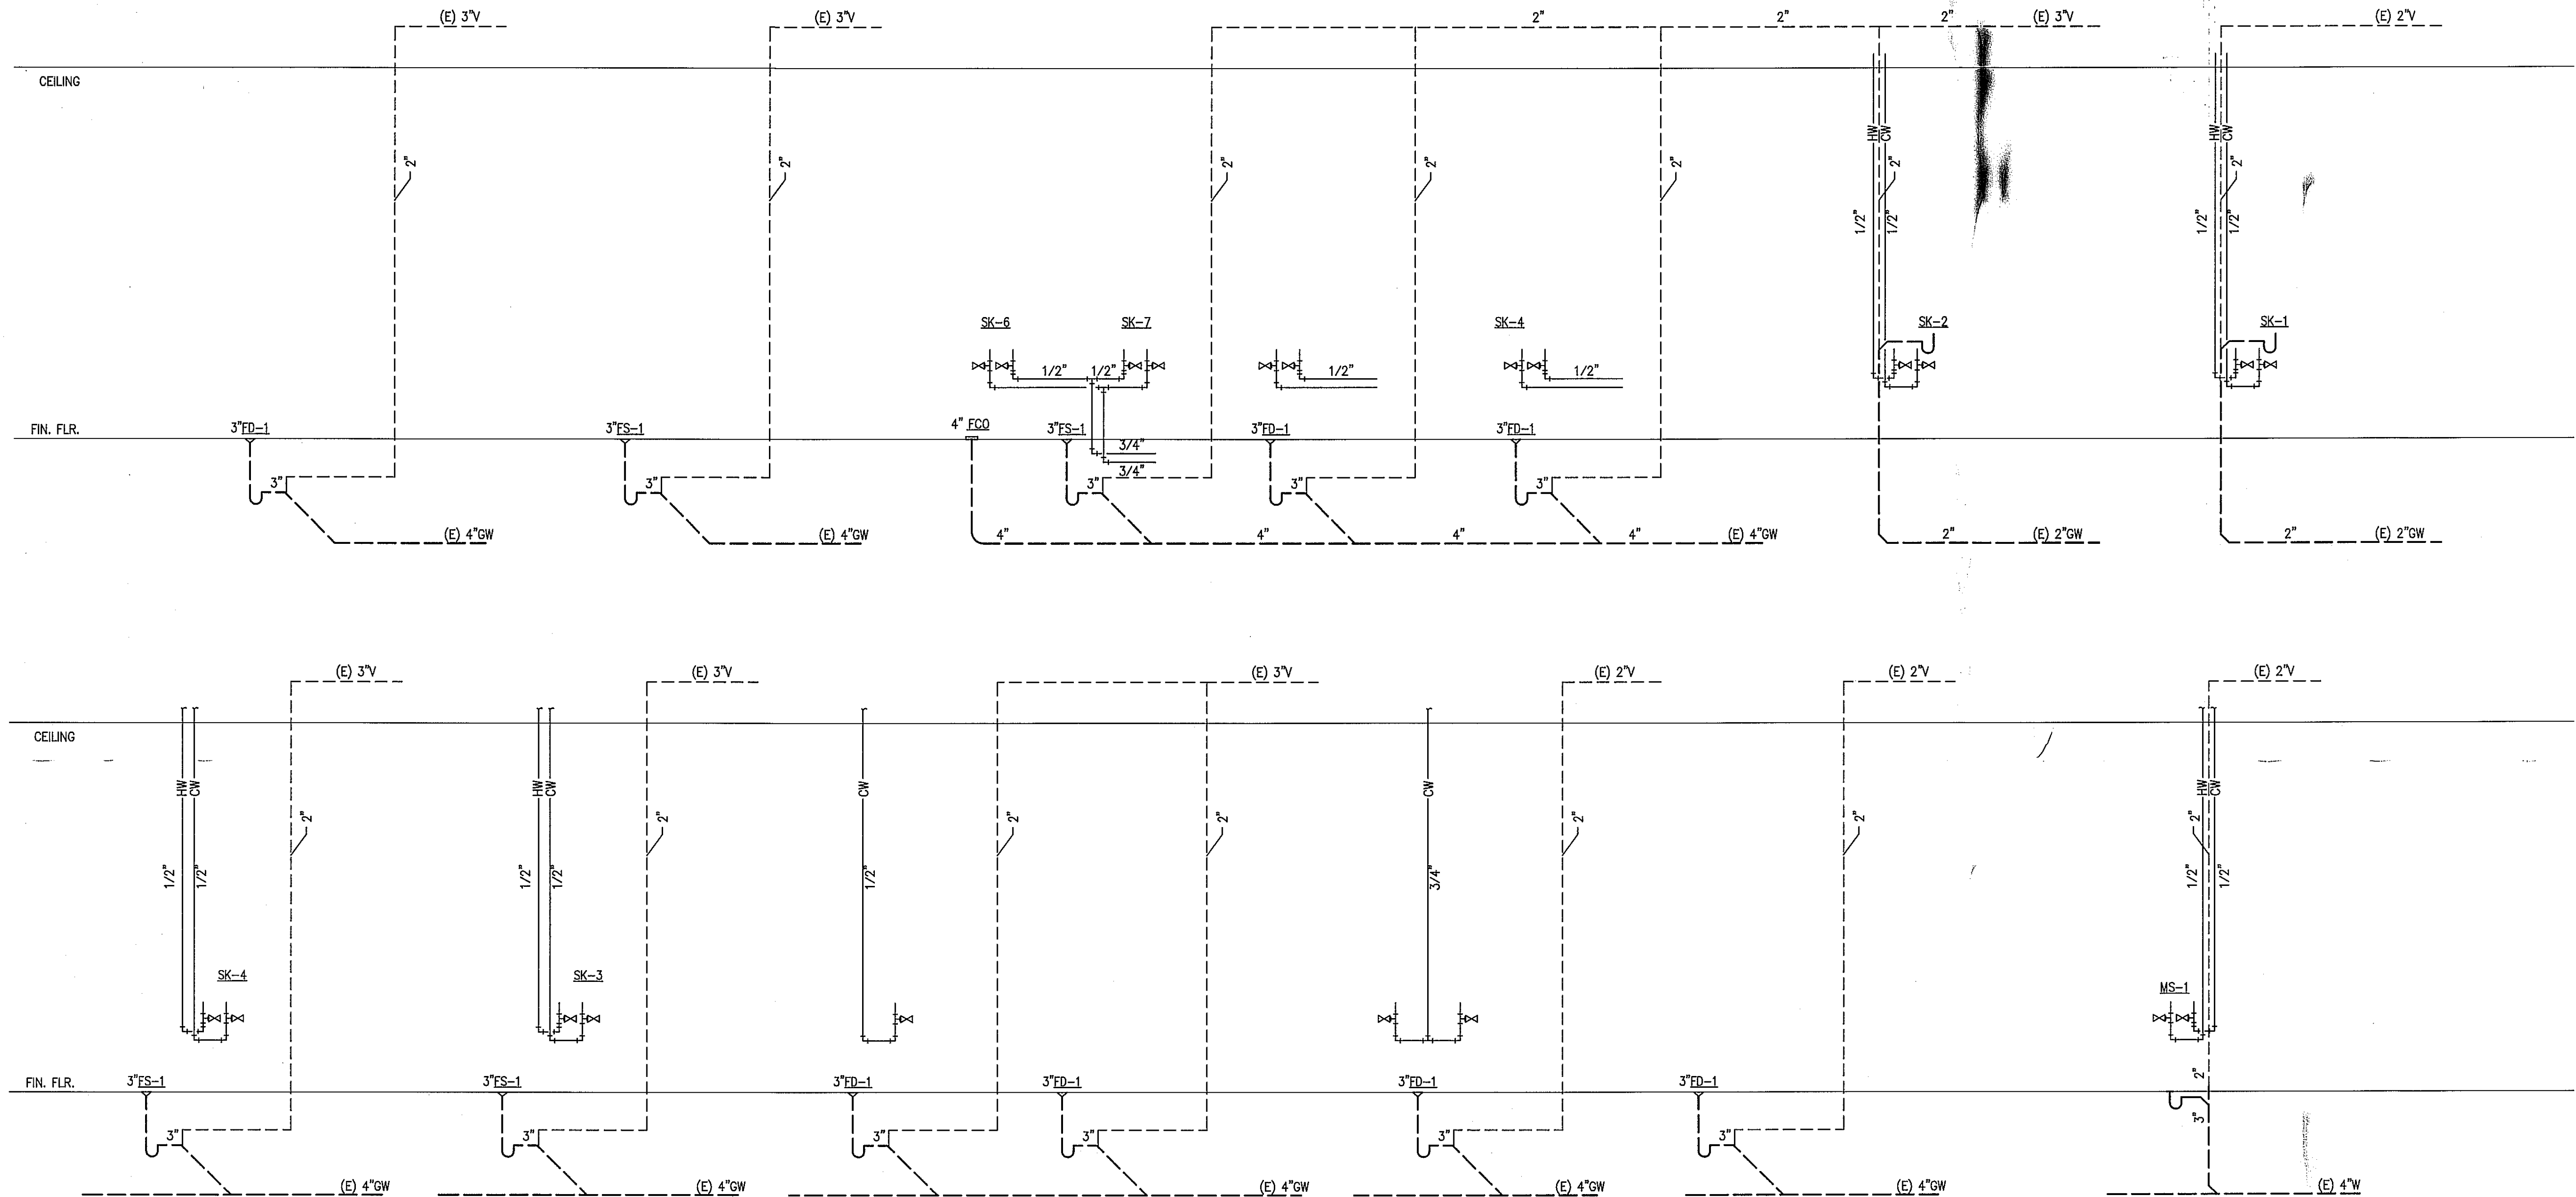

1 PLUMBING RISER DIAGRAMS
SCALE: NONE