

# LIGHT FIXTURE SCHEDULE

REFER TO A2.1


# CEILING PLAN NOTES

ALL HVAC AND ELECTRICAL LIGHTING DESIGN SHALL BE DESIGN / BUILD. THIS PLAN IS FOR GENERAL LOCATION ONLY, AND IS INTENDED ONLY FOR DESIGN INTENT.

REFER TO MECHANICAL DOCUMENTS FOR HVAC SPECIFICATIONS. COORDINATE WITH ARCHITECT FOR EXACT LOCATIONS. ALL EXPOSED GRILLS SHALL BE FINISH: MATCH CEILING OR WALL COLOR

ALL WALL BOX DIMMERS SHALL RETAIN A MINIMUM ELECTRICAL LOAD OF 1500-2000 WATTS.

- ① VERIFY HEIGHT OF OUTLETS W/ ARCHITECT
- ② (3) HEAVY TIMBER DECORATIVE TRUSSES NATURAL STAIN, SEE SECTION 12/A4.3
- ③ GYP. BD. BULKHEAD 1'-11" A.F.F.
- ④ GREEN BOARD CEILING, (PAINT PT-1)
- ⑤ GYP. BD. BULKHEAD 6'-6" A.F.F.

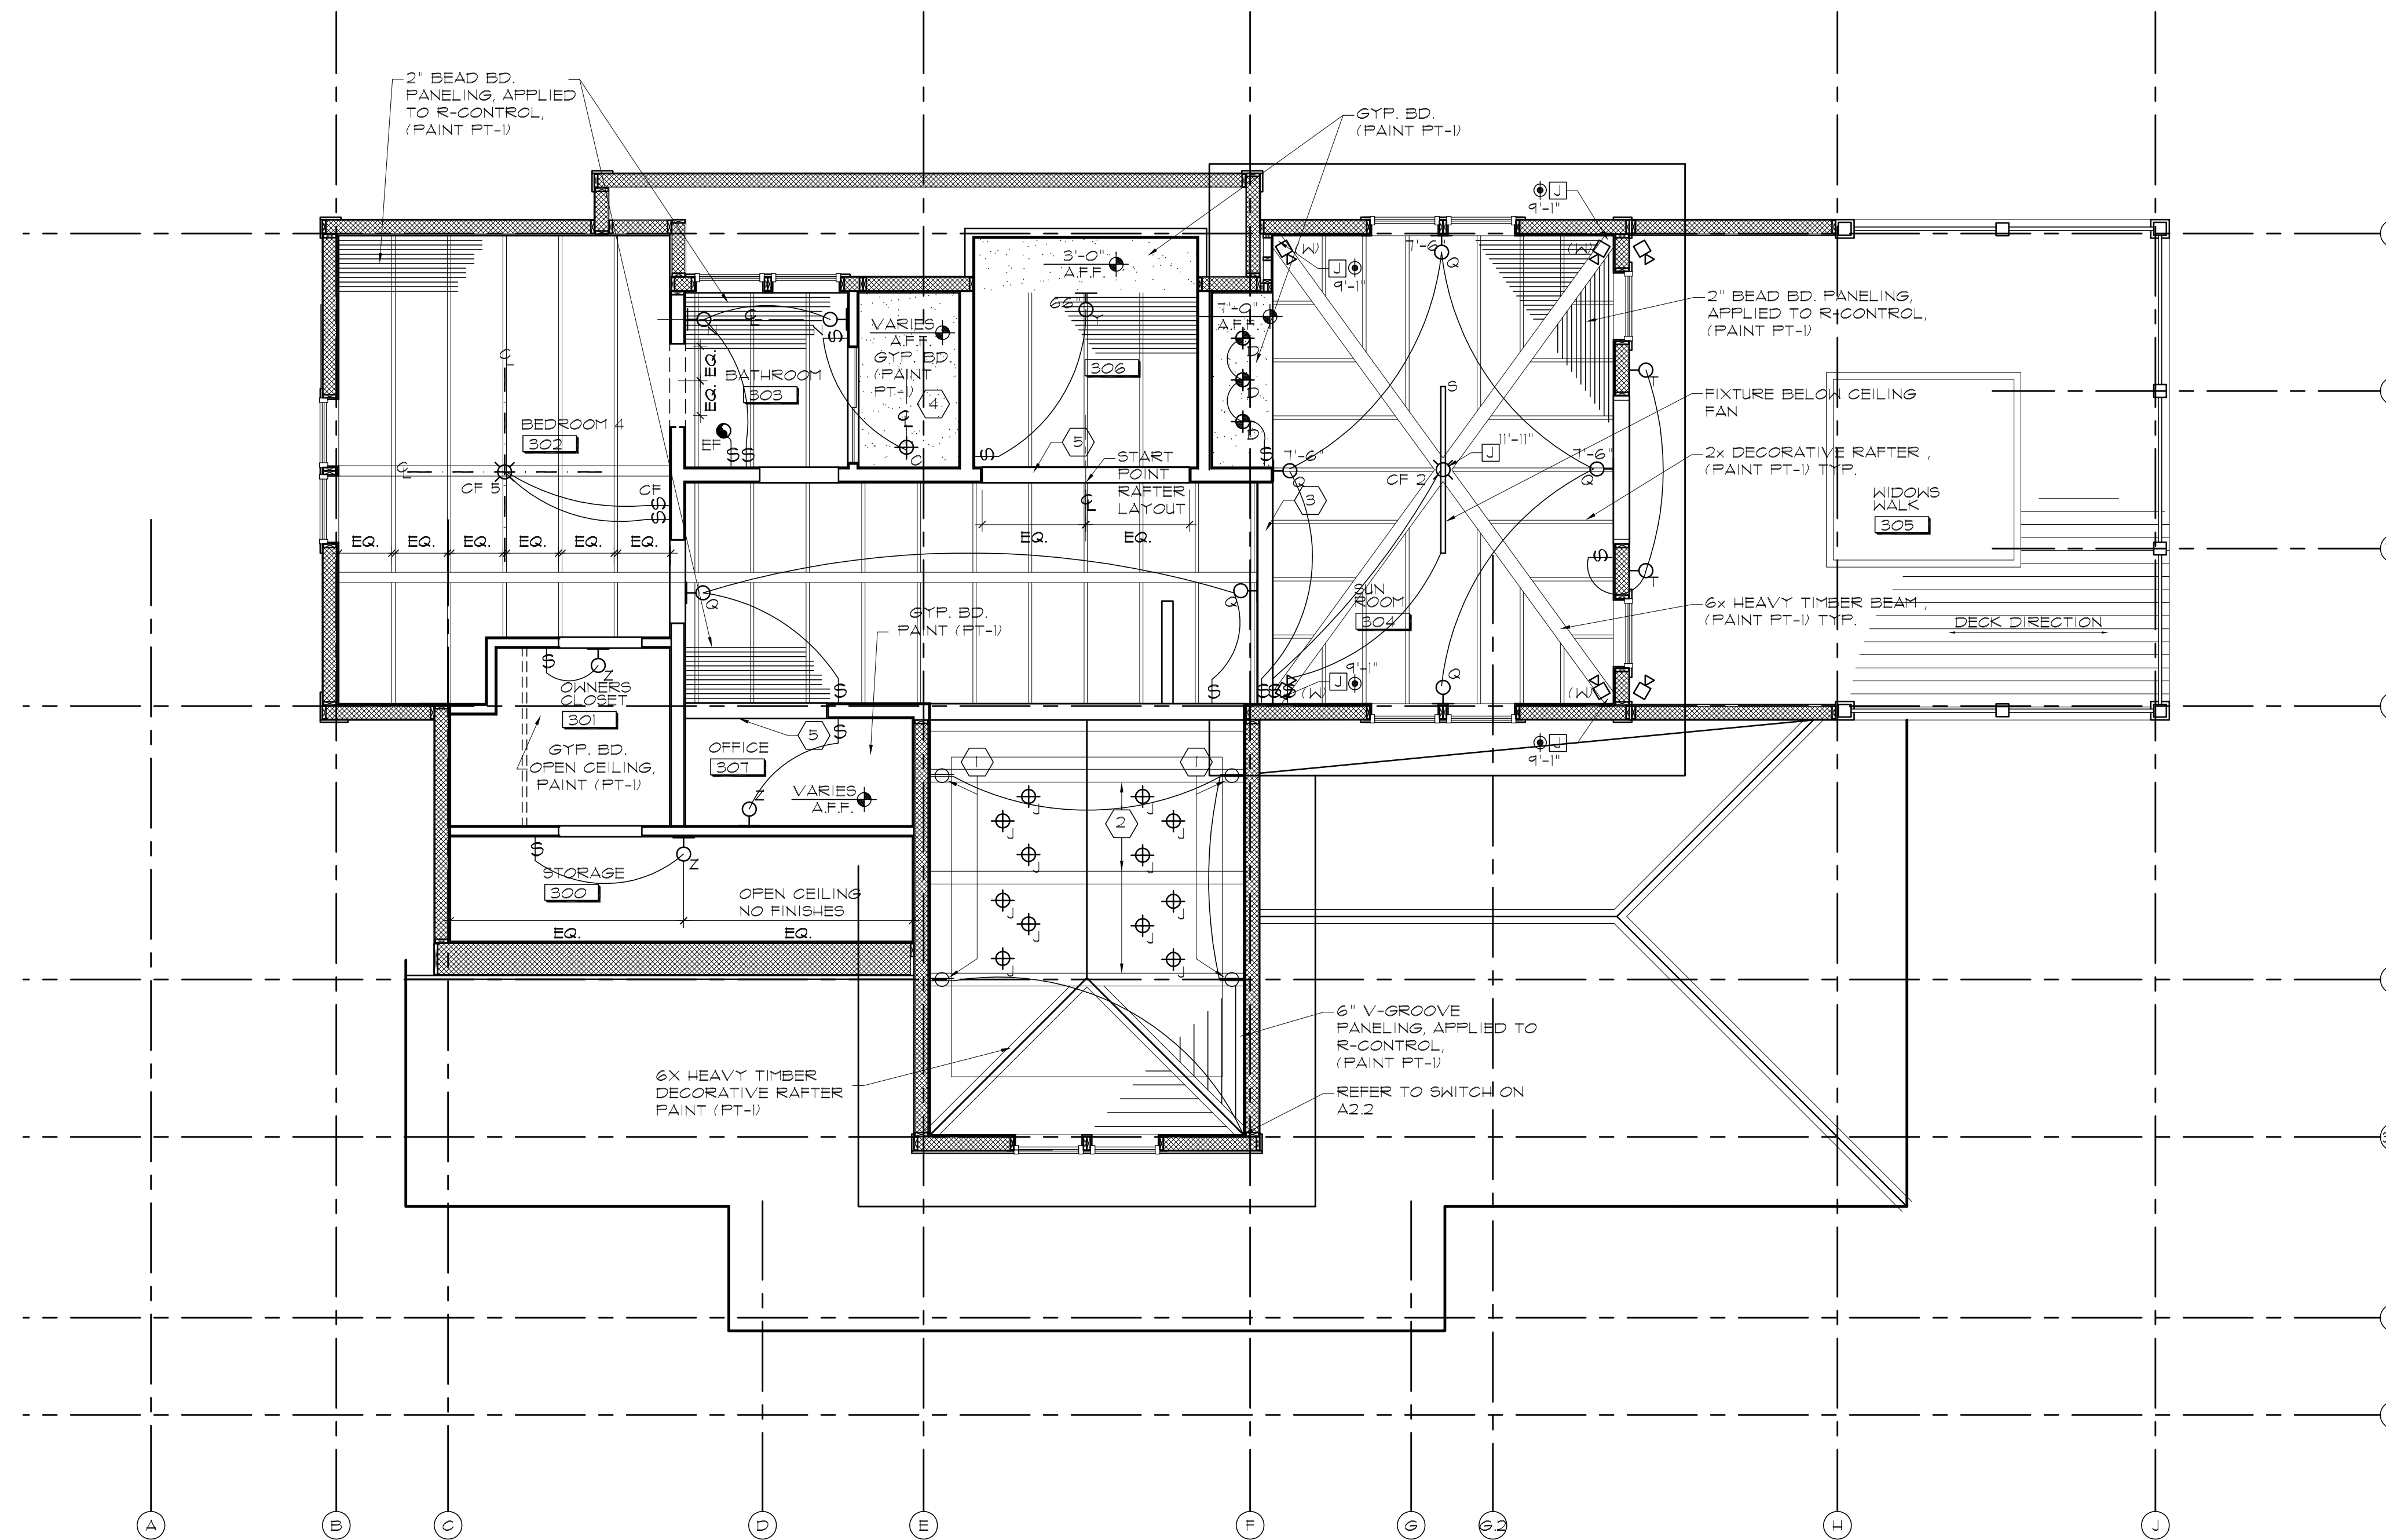


## CEILING LEGEND


- |              |   |
|--------------|---|
| ROOM NAME    | ROOM NAME & NUMBER  |
| ②01          | ROOM NAME & NUMBER  |
| ⑥            | CEILING PLAN NOTE   |
| ① A31        | DETAIL TAG & ENLARGED PLAN, INDICATES DETAIL #1 ON SHEET A3.1   |
| 0'-0" A.F.F. | INDICATES CEILING HEIGHT  |
| ○            | RECESSED CEILING FIXTURE  |
| ●            | RECESSED CEILING FIXTURE / SPEAKER  |
| CF           | CEILING FAN   |
| ⊗            | CEILING MOUNTED LIGHT FIXTURE, VERIFY W/ ARCHITECT EXACT LOCATION & HEIGHT, BEFORE ROUGH-IN INSTALLATION. |
| ⊕            | SUSPENDED LIGHT FIXTURE, VERIFY W/ ARCHITECT EXACT LOCATION & HEIGHT, BEFORE ROUGH-IN INSTALLATION.       |
| ⊙            | RECESSED ADJUSTABLE ACCENT LIGHT FIXTURE  |
| ⊖            | WALL MOUNTED LIGHT FIXTURE, VERIFY W/ ARCHITECT EXACT LOCATION & HEIGHT, BEFORE ROUGH-IN INSTALLATION.    |
| ▲            | TRACK MOUNTED LIGHT FIXTURE, VERIFY W/ ARCHITECT EXACT LOCATION & HEIGHT, BEFORE ROUGH-IN INSTALLATION.   |
| ⊕            | INDICATES SWITCH NUMBER   |
| ⊕A           | INDICATES FIXTURE TYPE  |
| ⊕            | ONE WAY SWITCH  |
| ⊕B           | THREE WAY SWITCH  |
| ⊕D           | INDICATES SWITCH W/ DIMMER  |
| ⊕G           | INDICATES FIXTURES GANGED BY AREA   |
| ⊕E           | INDICATES SWITCH TO EXHAUST FAN   |
| ⊕F           | INDICATES SWITCH TO CEILING FAN   |
| ⊕            | INDICATES FIXTURE TO BE SWITCHED  |
| ●            | EXHAUST FAN / LIGHT (EF)  |
| ⊙            | SMOKE DETECTOR  |
| ⊠            | JUNCTION BOX  |
| ⊠            | OUTDOOR FOURPLEX  |
| ⊕            | VIDEO CABLE CONNECTION CABLE OR SATELLITE, SEE DETAIL   |
| ⊠            | SPEAKER, JUNCTION BOX IN CLG OR WALL ● 1'-0" AFF U.N.O.   |

## TOWER LEVEL CEILING PLAN

SCALE: 1/4"=1'-0"

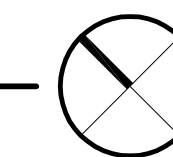

**THE GRUENE HOUSE**  
 CINNAMON SHORE  
 175 SEASIDE DR.  
 PORT ARANSAS, TX 78373

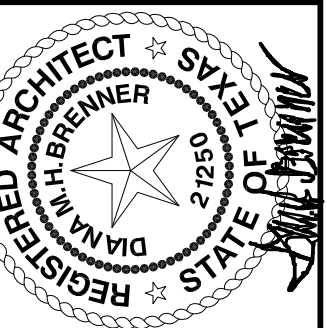

620 N. Delaware  
 Indianapolis, IN 46204  
 317.262.1200 tel.  
 317.262.1200 fax  
 www.brennerdesign.com

**BRENNER DESIGN**  
 Architecture  
 Construction Management

SHEET NO.

TOWER LEVEL REFLECTED CEILING PLAN

A2.3

CIN3401R

1 JUN 13